

Stantec Hydrock Limited
Third Floor, Wharton Place, 13 Wharton Street
Cardiff
CF10 1GS
Tel. +44 (0)2920 023665
www.stantec.com/uk

Copyright Reserved

The Copyrights to all designs and drawings are the property of Stantec Hydrock Limited. Reproduction or use for any purpose other than that authorised by Stantec is forbidden.

The Contractor shall verify and be responsible for all dimensions. DO NOT scale the drawing. Any errors or omissions shall be reported to Stantec without delay.

Colour Disclaimer

This drawing has been documented in colour. This drawing is required to be printed in colour. Failure to do so may result in loss of information. Black and white printing may be used if specific black and white documents have been obtained from Stantec.

- KEY**
- SITE BOUNDARY
 - PROPOSED SURFACE WATER SEWER
 - PROPOSED SURFACE WATER MANHOLE
 - PROPOSED SURFACE WATER HEADWALL
 - PROPOSED SURFACE WATER GULLY
 - PROPOSED FOUL WATER SEWER
 - PROPOSED FOUL WATER RISING MAIN
 - PROPOSED FOUL WATER MANHOLE
 - PROPOSED FOUL WATER PUMPING STATION
 - PROPOSED WILDERNESS DRAIN DIVERSION 1200mmØ
 - PROPOSED 600mmØ DRAIN DIVERSION
 - EXISTING DCWW SURFACE WATER SEWER
 - EXISTING FOUL WATER SEWER
 - EXISTING DCWW COMBINED WATER SEWER
 - EXISTING DCWW COMBINED WATER RISING MAIN
 - EXISTING HIGHWAY DRAIN
 - EXISTING WILDERNESS DRAIN 1100mmØ
 - EXISTING 600mmØ DRAIN
 - SEWER DIVERSION
 - PROPOSED PUMPING STATION AREA
 - SURFACE WATER SWALE
 - 6m SEWER EASEMENT
 - INFILTRATION BASIN

DRAWING HAS BEEN PRODUCED BASED ON INFORMATION FROM EXISTING GPR SURVEY AND DCWW'S ASSET MAP WEBSITE WITH ASSUMPTIONS MADE. ANY FUTURE OUTLINE OR DETAILED DESIGN TO BE UNDERTAKEN MUST BE ACCOMPANIED BY IMPROVED DRAINAGE MAPPING SURVEYS, CAMERA SURVEYS, GPR SURVEYS AND IN SOME LOCATIONS, TRIAL PITTING TO DETERMINE EXACT LOCATIONS, CONNECTIVITY, SIDE CONNECTIONS AND ACCURATE EASEMENT POSITIONS.

P01 - FIRST ISSUE	EN	KG	16/10/2025
Issued/Revision	By	Appd	DD.MM.YYYY
	EN	KG	KG
	Dwn.	Dsgn.	Chkd.
			16/10/2025
			DD.MM.YYYY

Issue Status

S1 - FOR COORDINATION

This document is suitable only for the purpose noted above. Use of this document for any other purpose is not permitted.

Client/Project Logo


Client/Project
BRIDGEND COUNTY BOROUGH COUNCIL

PORHCRAWL WATERFRONT

Title

**PROPOSED DRAINAGE PLAN
SHEET 2**

Project No. 333700659	A1 Scale 1:1000
Revision P01	Drawing No. 32485-STN-XX-XX-DR-C-0302

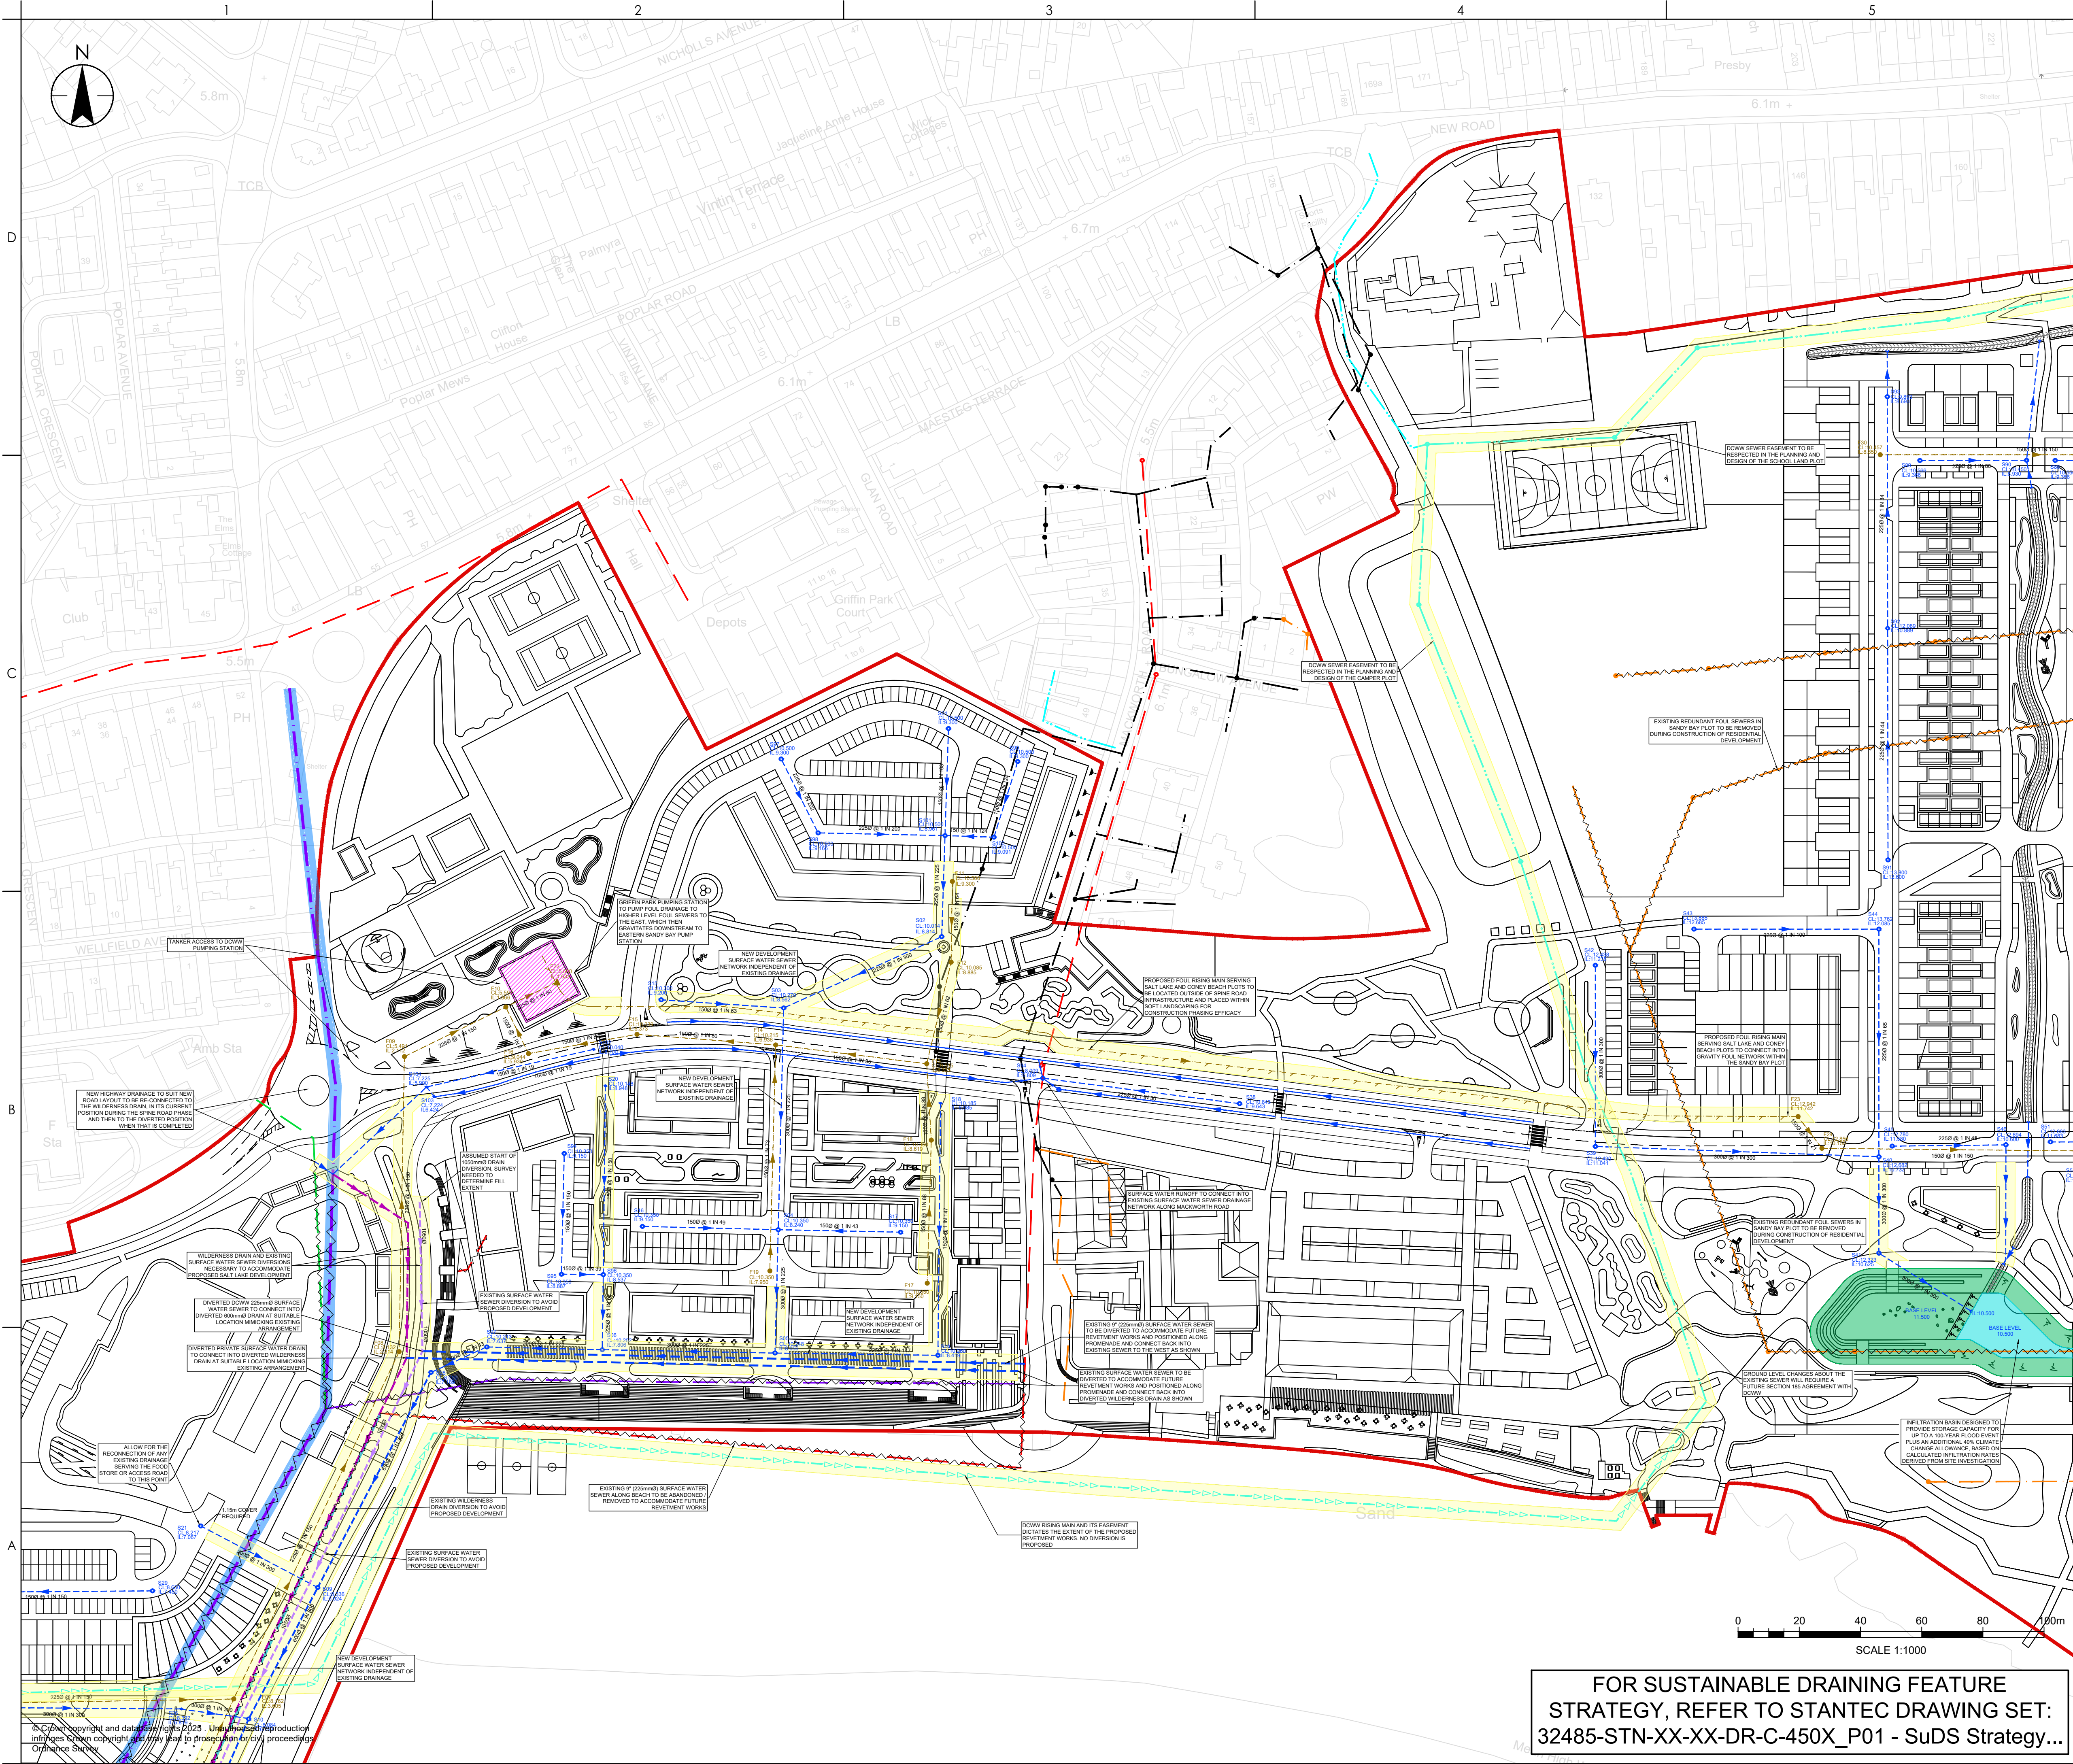

**FOR SUSTAINABLE DRAINING FEATURE
STRATEGY, REFER TO STANTEC DRAWING SET:
32485-STN-XX-XX-DR-C-450X_P01 - SuDS Strategy...**